


KCP&L, LAKE ROAD GENERATING STATION, ST. JOSEPH, MISSOURI

P & ID NUMBER	Drawing Index	P & ID Title
SU-XXXXX-PID-01	Auxiliary Cooling Water System - Sheet 1	
SU-XXXXX-PID-02	Auxiliary Cooling Water System - Sheet 2	
SU-XXXXX-PID-03	Auxiliary Cooling Water System - Sheet 2 - Page 2	
SU-XXXXX-PID-03-01	Auxiliary Cooling Water System - Sheet 1	
SU-XXXXX-PID-03-02	Auxiliary Cooling Water System - Sheet 2	
SU-XXXXX-PID-03-03	Auxiliary Cooling Water System - Sheet 2 - Page 2	

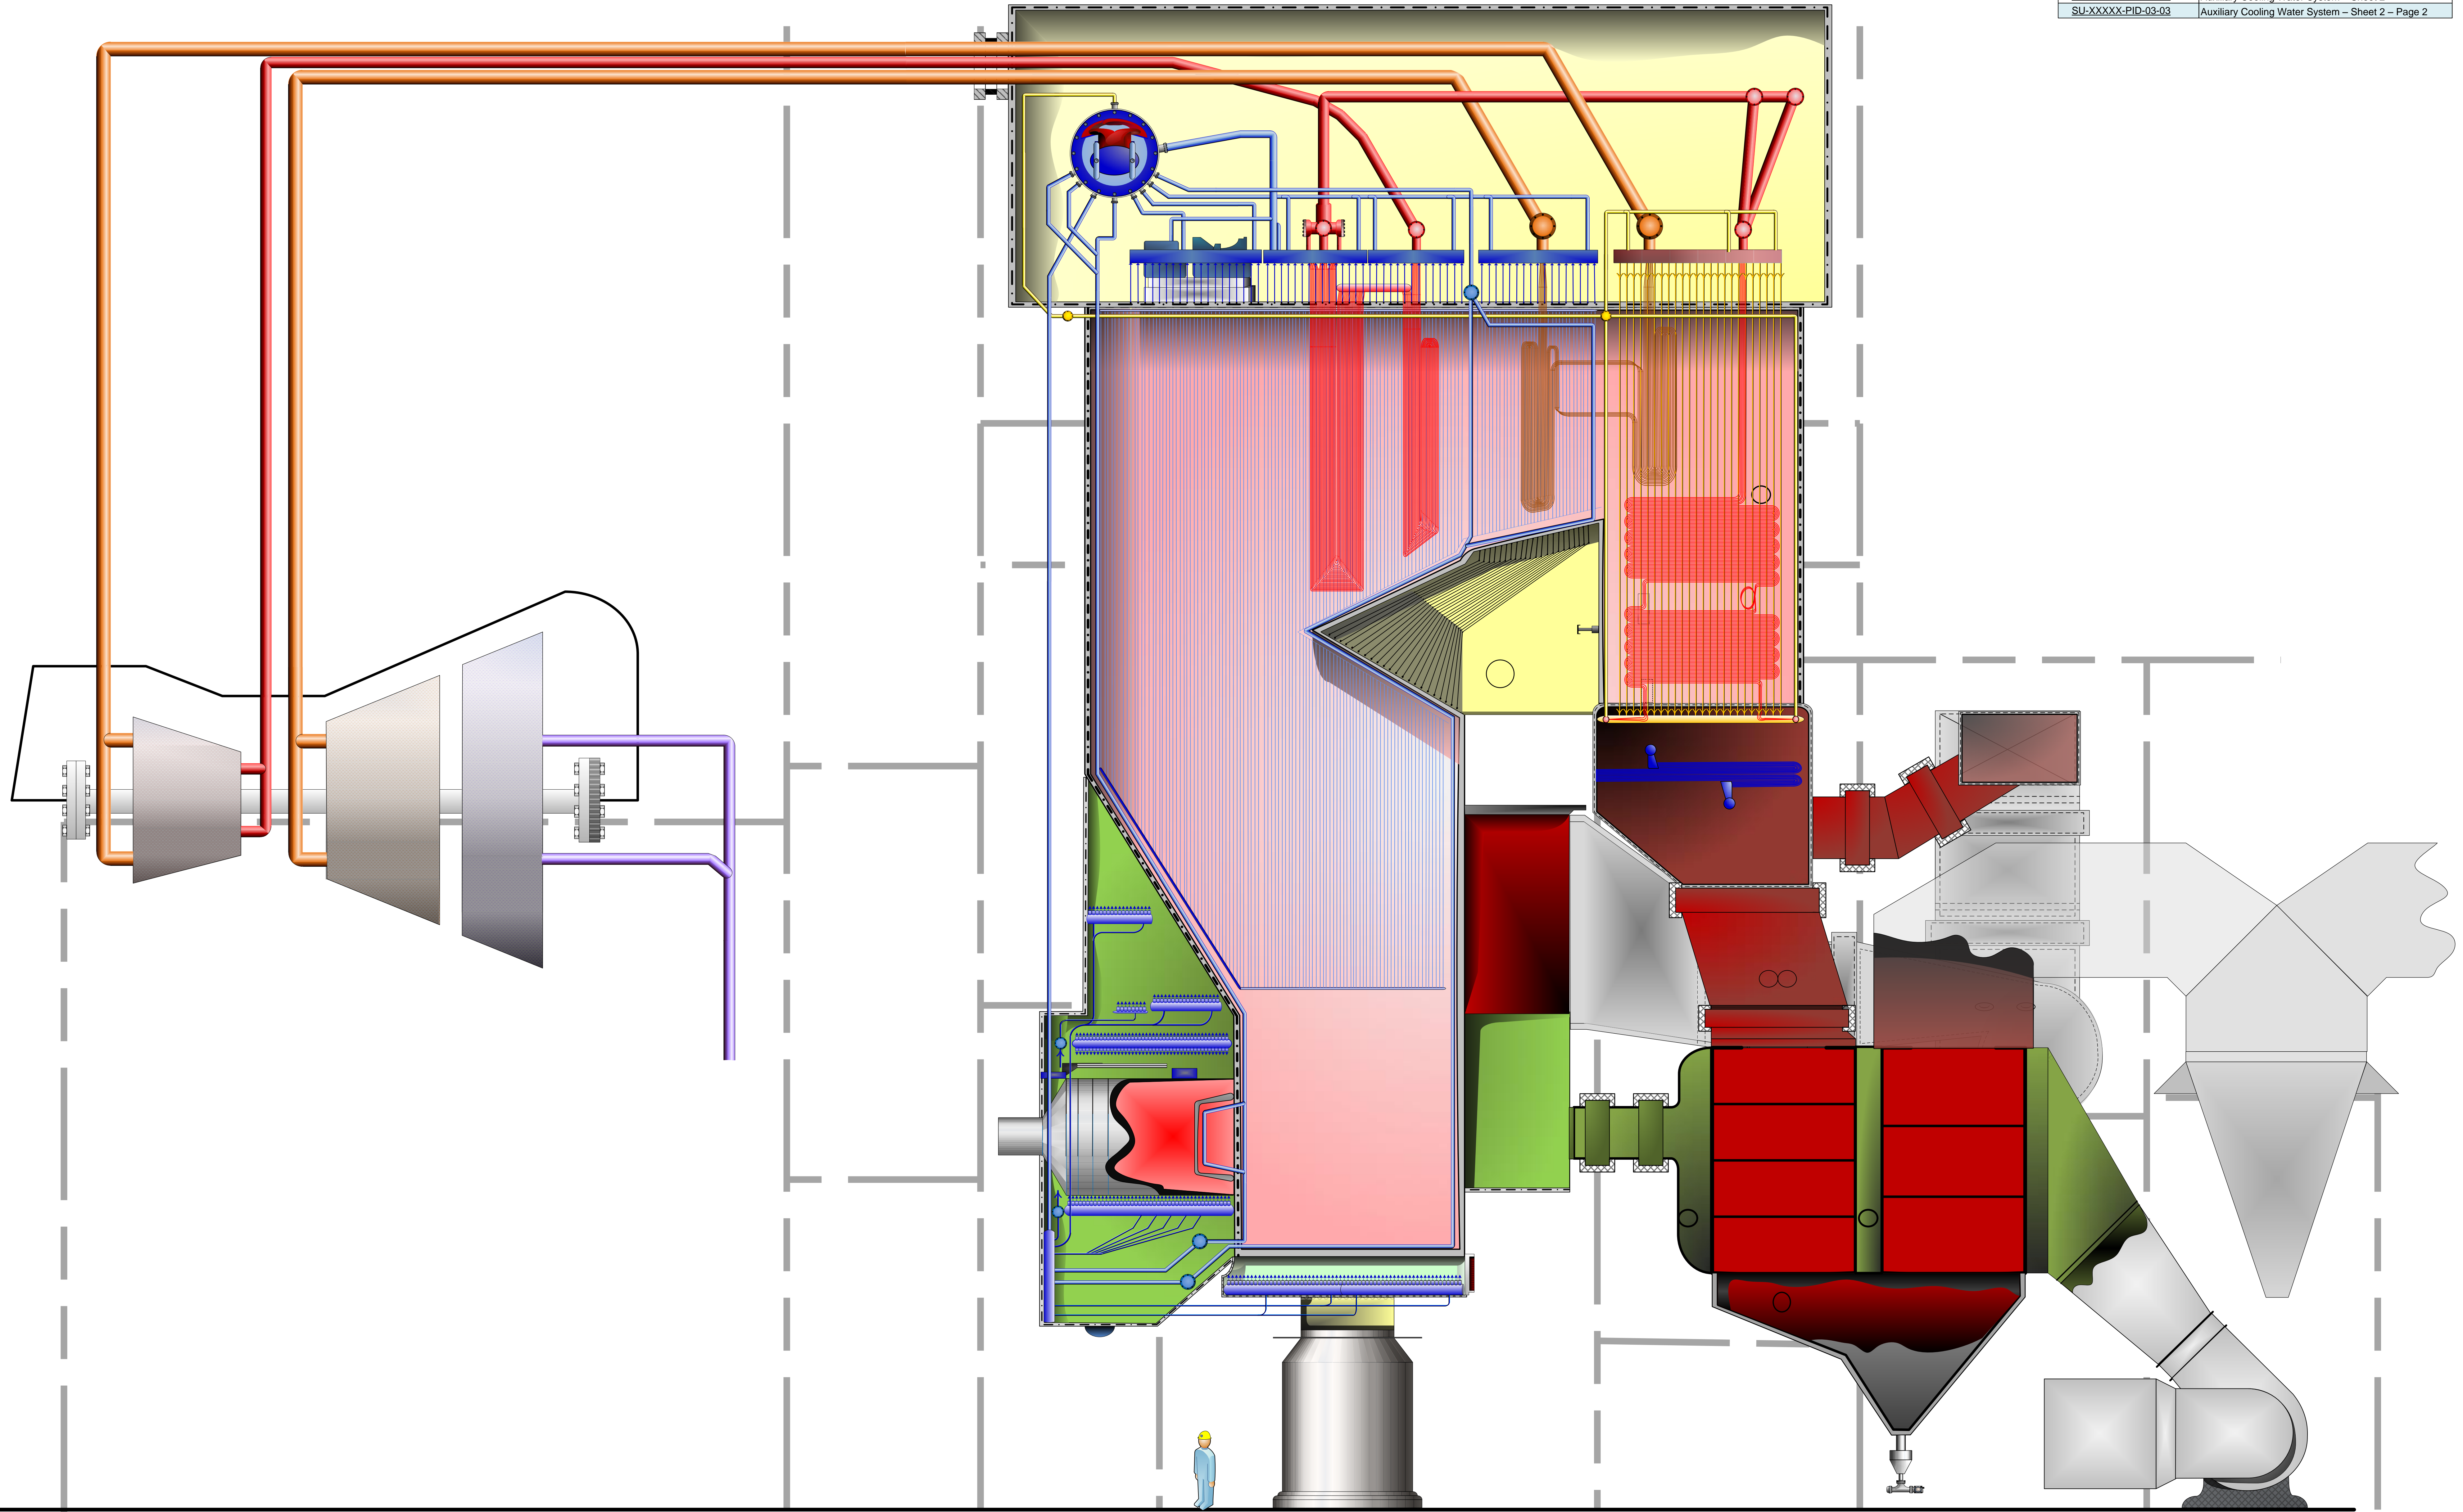

- NOTES:**
- Blue -- BOILER FEEDWATER
 - Yellow -- WATER/STEAM MIX (FURNACE WALL TUBES & RISERS)
 - Red -- CONVECTION PASS STEAM
 - Orange -- SUPERHEAT & MAIN STEAM
 - Brown -- REHEATER, COLD REHEAT, HOT REHEAT STEAM
 - Purple -- LOW PRESSURE STEAM

THIS DIAGRAM IS NEITHER ENGINEERED OR INTENDED TO BE USED AS A P&ID. IT IS BASED ON THE LARGEST AVAILABLE PHOTOS AND IMAGES OF AN ORIGINAL SIMILAR DIAGRAM LOCATED AT KCP&L LAKE ROAD GENERATING SITE IN ST. JOSEPH, MISSOURI.

Drawing Legend

REV.	DESCRIPTION	DATE	BY	SCALE	SYSTEM CODE	DWG NO	REV
A	ORIGINAL DIAGRAM FROM INFO PROVIDED	12/21/2010	DAH		BOILER	LR46-BOILER-PID	0
B	UPDATE OF DIAGRAM TO NEW FORMAT.	7/02/2011	DAH				

Kansas City Power & Light Lake Road Generating Facility		UNIT 4/6 PRINCIPLE PIPING DIAGRAM	
Boiler Water and Steam Systems			
SCALE	NONE	DRAWN	D.A. HOLDING
SHEET	1	TOTAL SHEETS	1 OF 1